

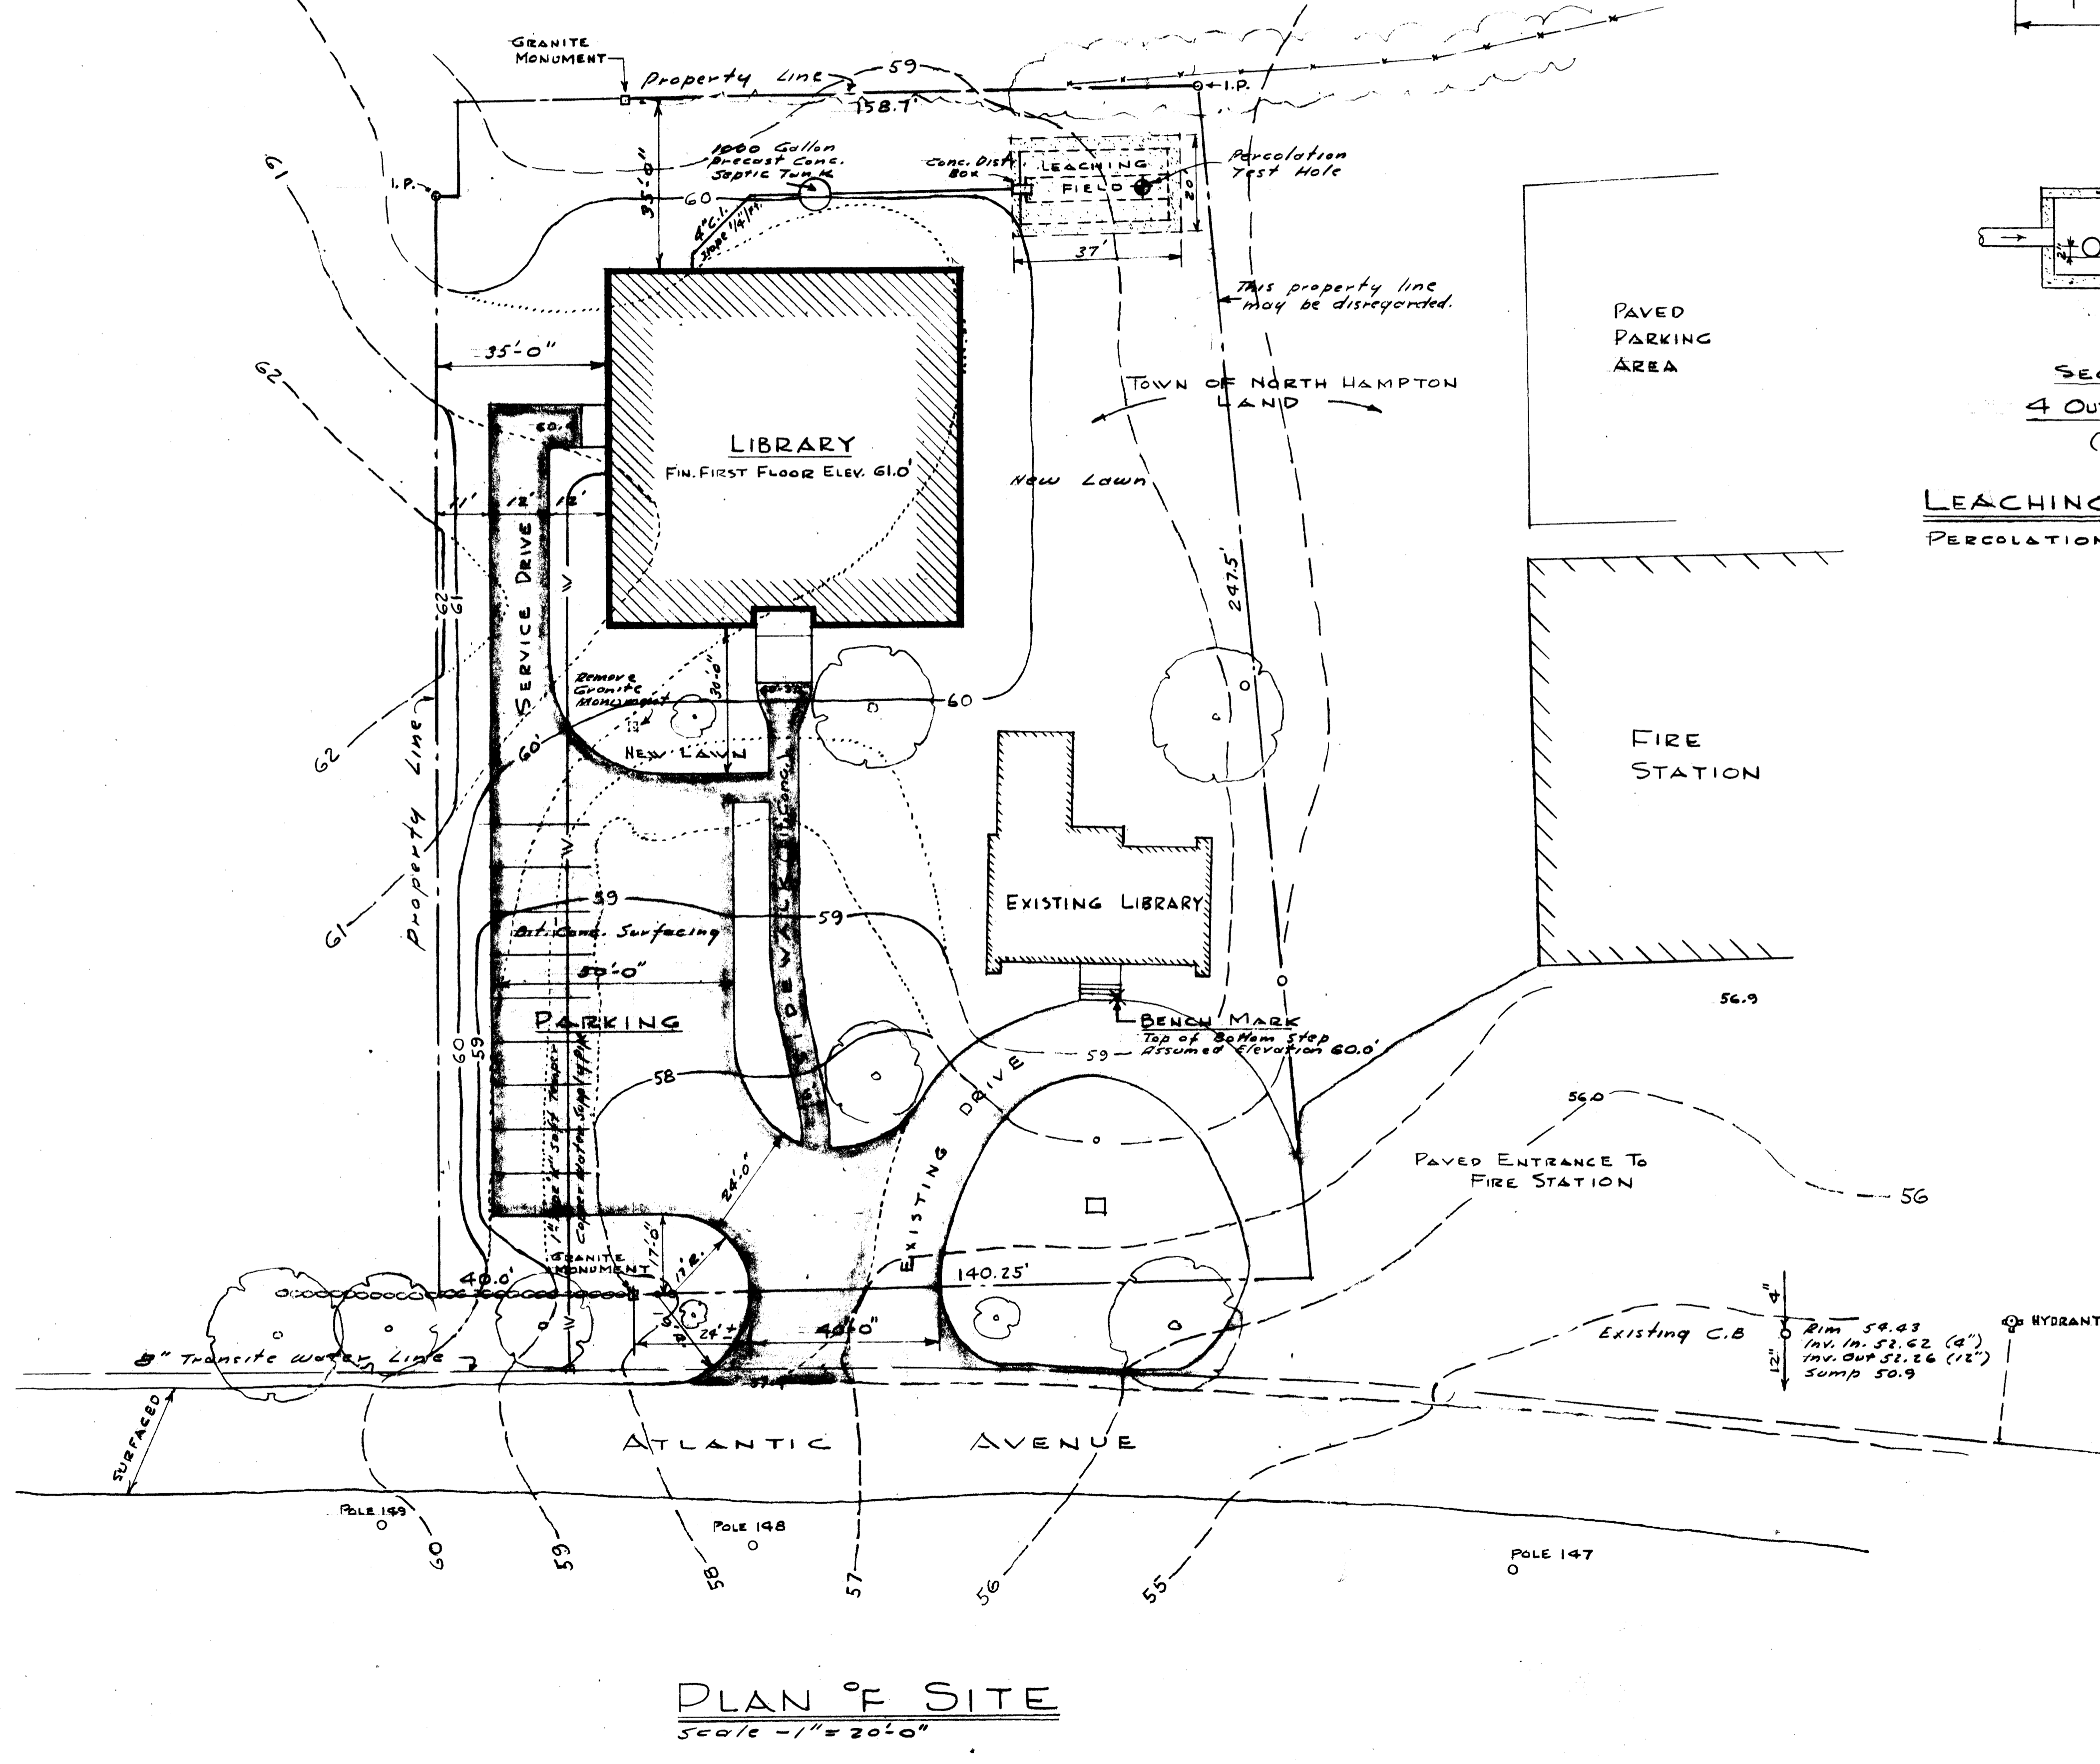
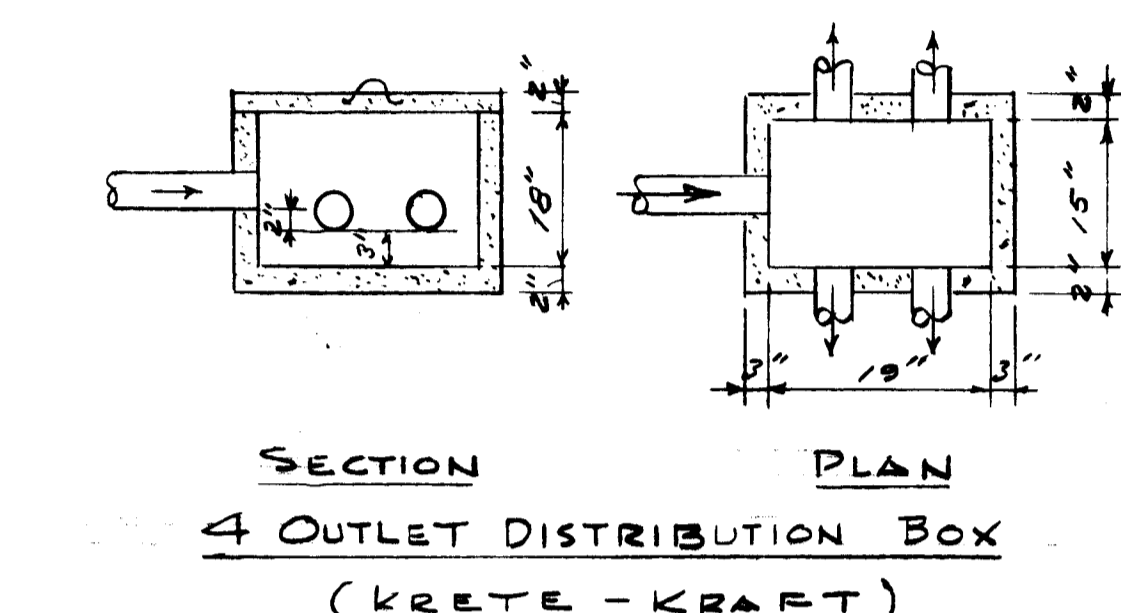
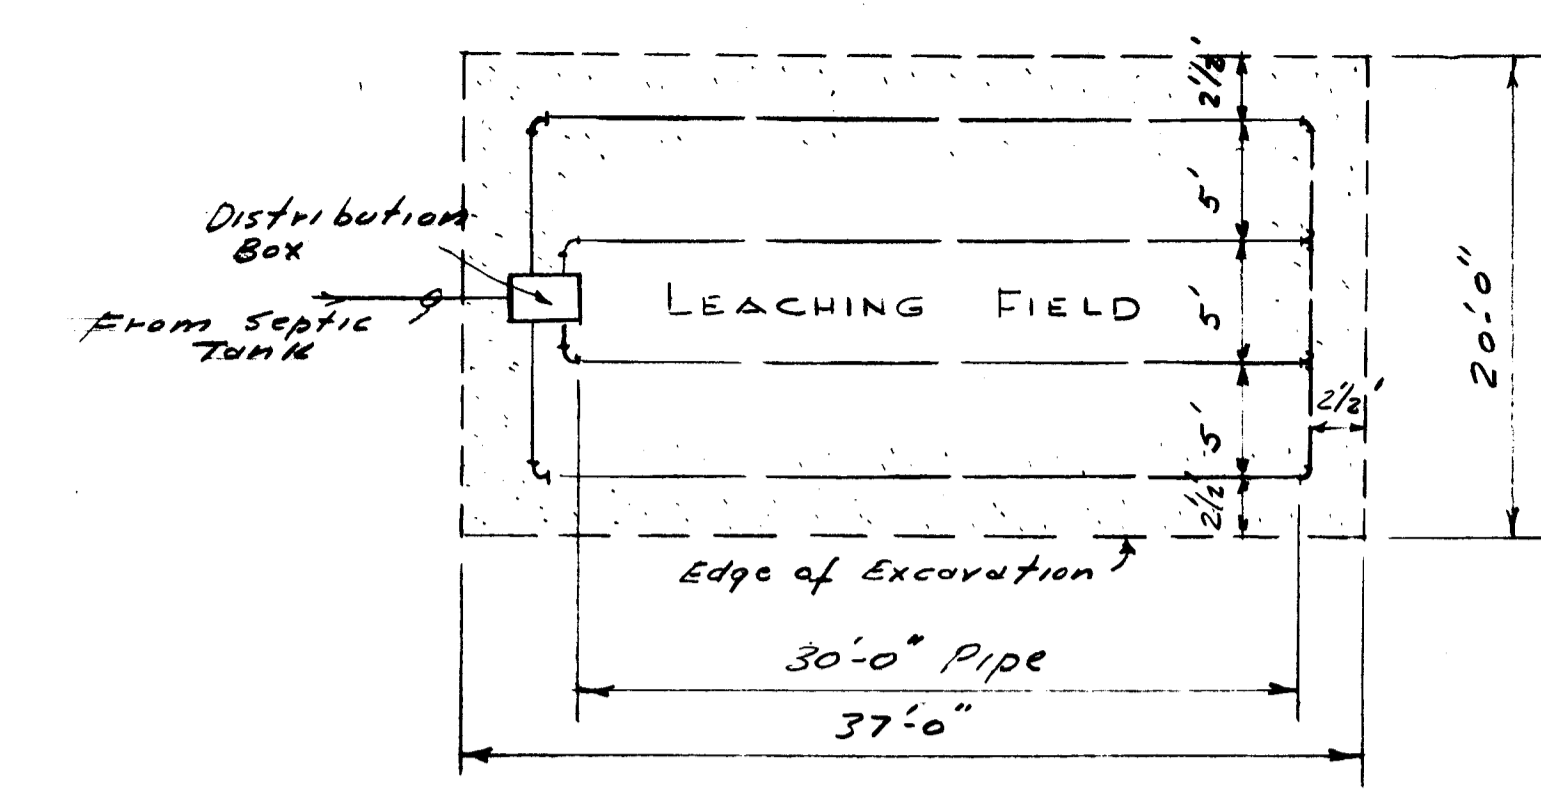


LIST OF DRAWINGS

ARCHITECTURAL	
1	Perspective
2	Plan of Site
3	Plan of Foundation
4	Plan of First Floor
5	Plan of Ceiling
6	Plan of Attic Floor Framing
7	Plan of Attic
8	Plan of Roof Framing
9	Plan of Roof
10	South and West Elevations
11	North and East Elevations
12	Wall Sections
13	Roof Truss Details
14	Roof Truss Details
15	Door Details
16	Window Details
17	Front Entrance Details
18	Interior Wall Elevations
19	Interior Details
HEATING, VENTILATING & AIR CONDITIONING	
H-1	First Floor Plan - Schedules
H-2	Attic Plan - Schedules
PLUMBING	
P-1	First Floor Plumbing Plan
P-2	Attic Plumbing Plan
ELECTRICAL	
E-1	Plan of First Floor Lighting
E-2	Plan of First Floor Power
E-3	Plan of Attic Lighting & Power

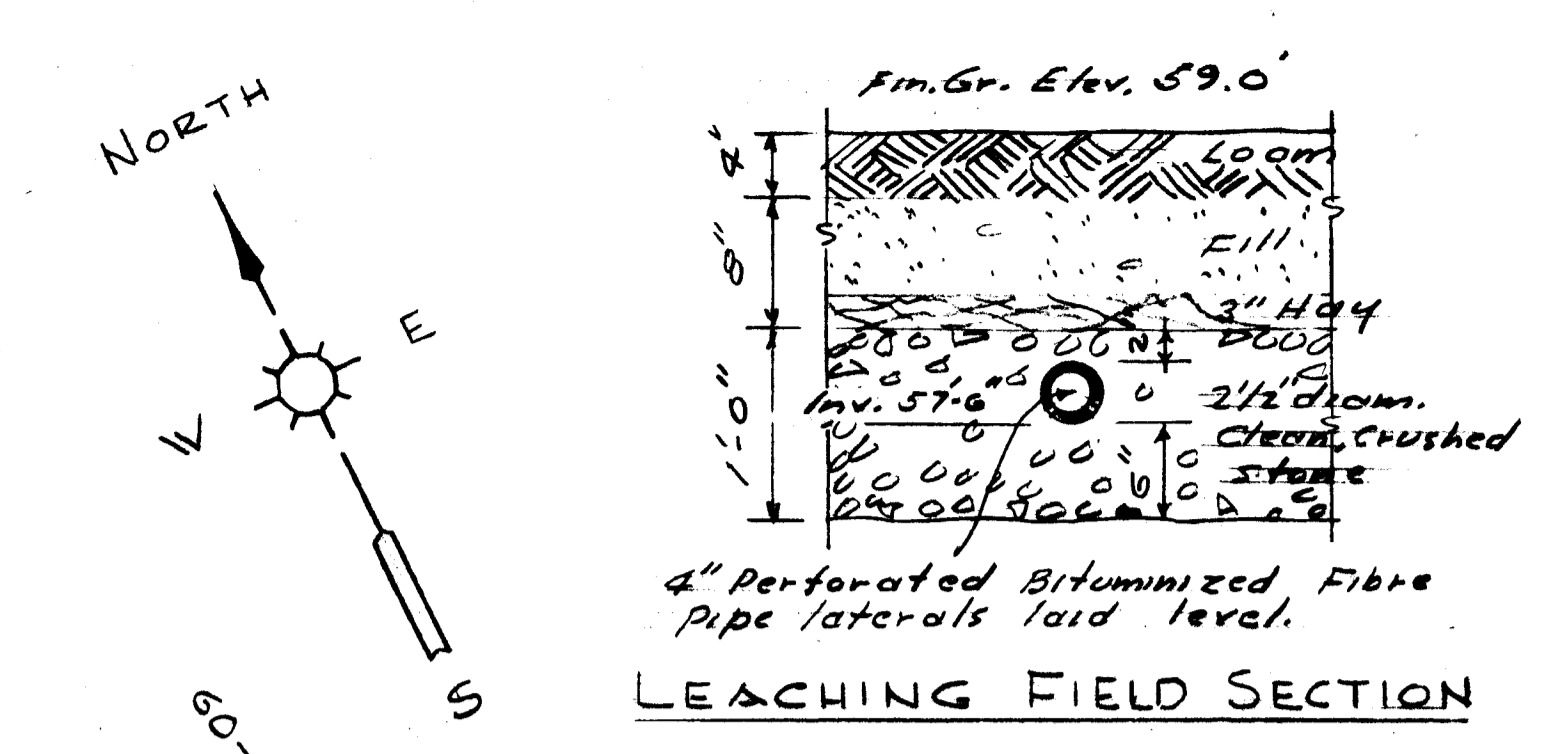

KEY TO DETAIL INDICATION & LOCATION

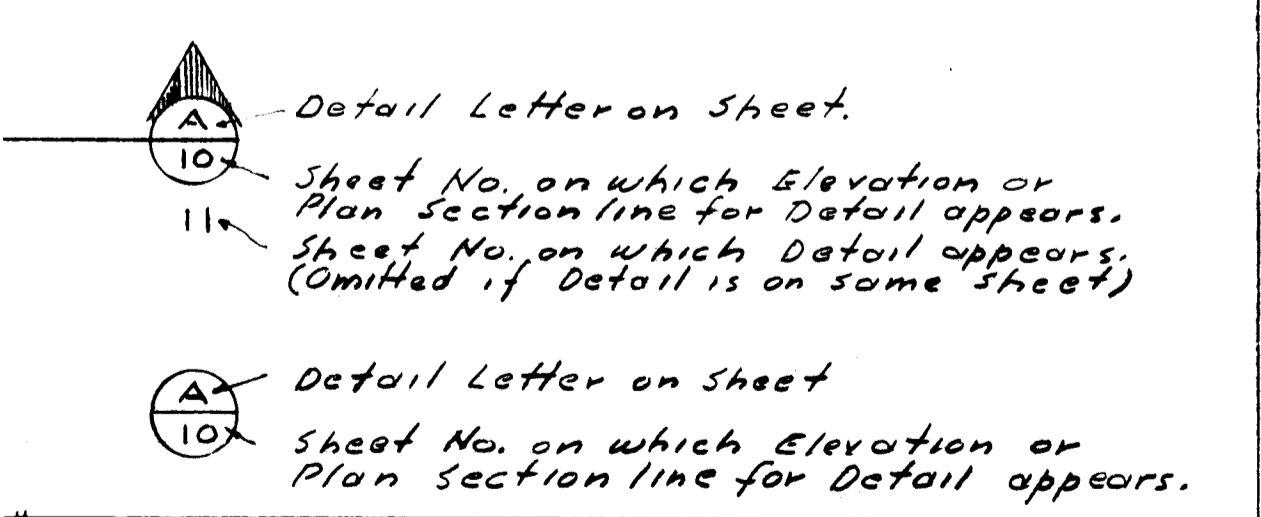

	PLAN OF SITE		
	New Library Building For NORTH HAMPTON PUBLIC LIBRARY Atlantic Avenue North Hampton, N. H.		
By	Date	Sheet No.	File No.
E.B.M.	June 15 1972	2	777
EDWARD BENTON MILES, A.I.A. Architect Exeter, New Hampshire			